


REVISIONS AND ISSUANCE		
NO.	DATE	DESCRIPTION
1	08/13/2017	PRICING
2	09/20/2018	PERMIT

IVY KIDS EARLY LEARNING CENTER
4434 CR 94
Manvel, Tx 77578



DRAWING TITLE	
REFLECTED CEILING PLAN	
DRAWN BY	CHECKED BY
DATE	JOB NO.
DRAWING NO.	

A-2.1

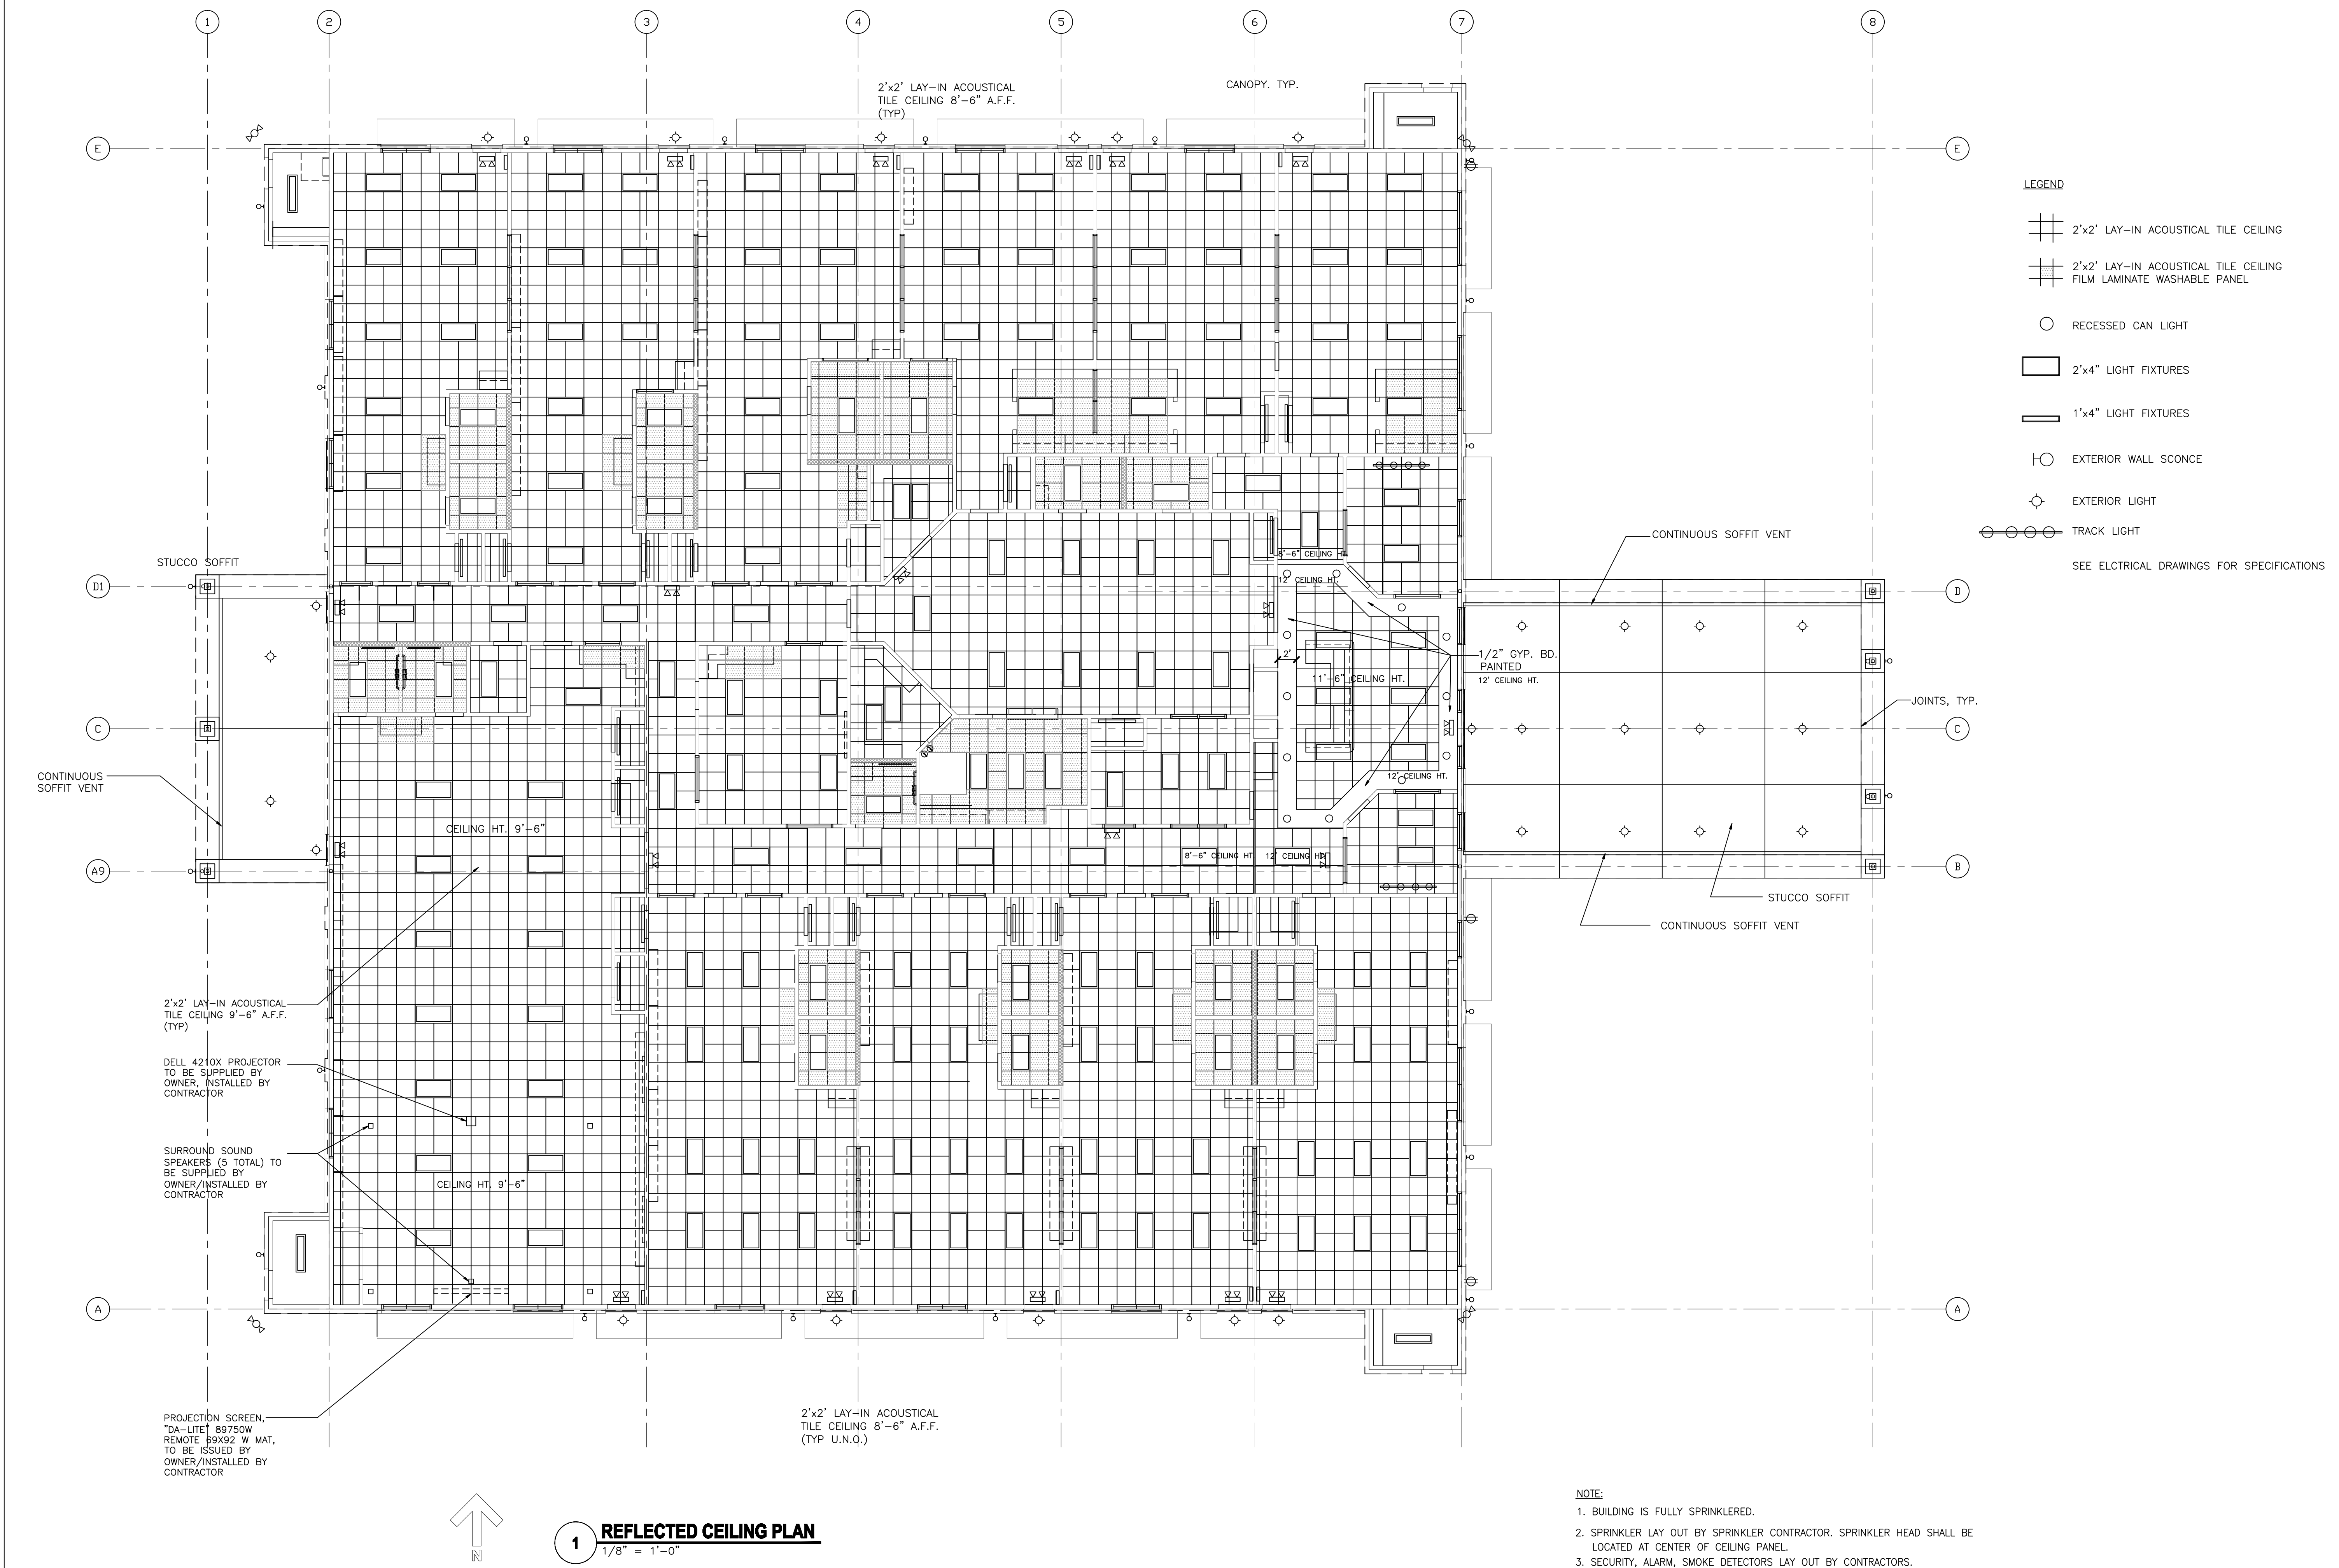

- LEGEND**
- 2'x2' LAY-IN ACOUSTICAL TILE CEILING
 - 2'x2' LAY-IN ACOUSTICAL TILE CEILING FILM LAMINATE WASHABLE PANEL
 - RECESSED CAN LIGHT
 - 2'x4" LIGHT FIXTURES
 - 1'x4" LIGHT FIXTURES
 - EXTERIOR WALL SCONCE
 - EXTERIOR LIGHT
 - TRACK LIGHT
- SEE ELECTRICAL DRAWINGS FOR SPECIFICATIONS

- NOTE:**
- BUILDING IS FULLY SPRINKLERED.
 - SPRINKLER LAY OUT BY SPRINKLER CONTRACTOR. SPRINKLER HEAD SHALL BE LOCATED AT CENTER OF CEILING PANEL.
 - SECURITY, ALARM, SMOKE DETECTORS LAY OUT BY CONTRACTORS.
 - ALL CEILING HEIGHTS AT 8'-6", RAISED CEILING AT LOBBY 12'-0"±, 9'-6" @ ACTIVITY ROOM, GYM, AND CLASSROOM #600.
 - CONCEAL ALL SPRINKLER HEADS WITH WHITE COVER PLATE.

1 REFLECTED CEILING PLAN
 1/8" = 1'-0"