


REVISIONS AND ISSUANCE		
NO.	DATE	DESCRIPTION
08/13/2018	PRICING	
08/31/2018	ISSUE FOR PERMIT	

GENERAL NOTE:

THE ROOF FRAMING SYSTEM IS DESIGN FOR ALL ROOF MOUNTED EQUIPMENT PER CURRENT BUILDING CODE. REFER TO STRUCTURE DRAWINGS FOR DETAILS

KEYED NOTES:

- 1 14/14 SUPPLY AND 24/10 RETURN AIR DUCTS UP TO RTU ON ROOF.
- 2 18/14 SUPPLY AND 24/12 RETURN AIR DUCTS UP TO RTU ON ROOF.
- 3 20/14 SUPPLY AND 24/14 RETURN AIR DUCTS UP TO RTU ON ROOF.
- 4 KITCHEN HOOD NO. 1, UL LISTED TYPE I HOOD WITH ANSUL R-102 FIRE SUPPRESSION SYSTEM.
- 5 10/10 KITCHEN HOOD EXHAUST DUCT DOWN AND CONNECT TO KITCHEN HOOD WITH TRANSITION. 10/10 KITCHEN HOOD EXHAUST DUCT UP TO EF-C ON ROOF. RE: DETAIL 02/M3.0
- 6 12"/8" SPLIT WITH SPLIT DAMPER.
- 7 2"x2" RETURN AIR GRILLE WITH 6" DEEP INSULATED PLENUM. (TYP. OF 2)
- 8 3"x2" RETURN AIR GRILLE.
- 9 2"x2" RETURN AIR GRILLE. (TYPICAL)
- 10 CEILING-MOUNT EXHAUST FAN. RUN FULL SIZE EXHAUST DUCT FROM FAN DISCHARGE TO ROOF CAP.
- 11 6" DRYER EXHAUST DUCT UP THRU ROOF TO VENT CAP ON ROOF. PROVIDE CLEANOUT FOR VERTICAL SECTION OF DRYER EXHAUST DUCT. DRYER EXHAUST DUCT SHALL BE TERMINATED WITH A BACKDRAFT DAMPER.
- 12 11"/9" SPLIT WITH SPLIT DAMPER.
- 13 FULL LOUVER DOOR BY GC.
- 14 PROVIDE 4" COMBUSTION AIR INTAKE AND FLUE EXHAUST PIPES FROM WATER HEATER UP THRU ROOF TO VENT TERMINAL AND COMBUSTION AIR INTAKE ON ROOF PER HEATER MANUFACTURER'S INSTRUCTIONS AND RECOMMENDATIONS.

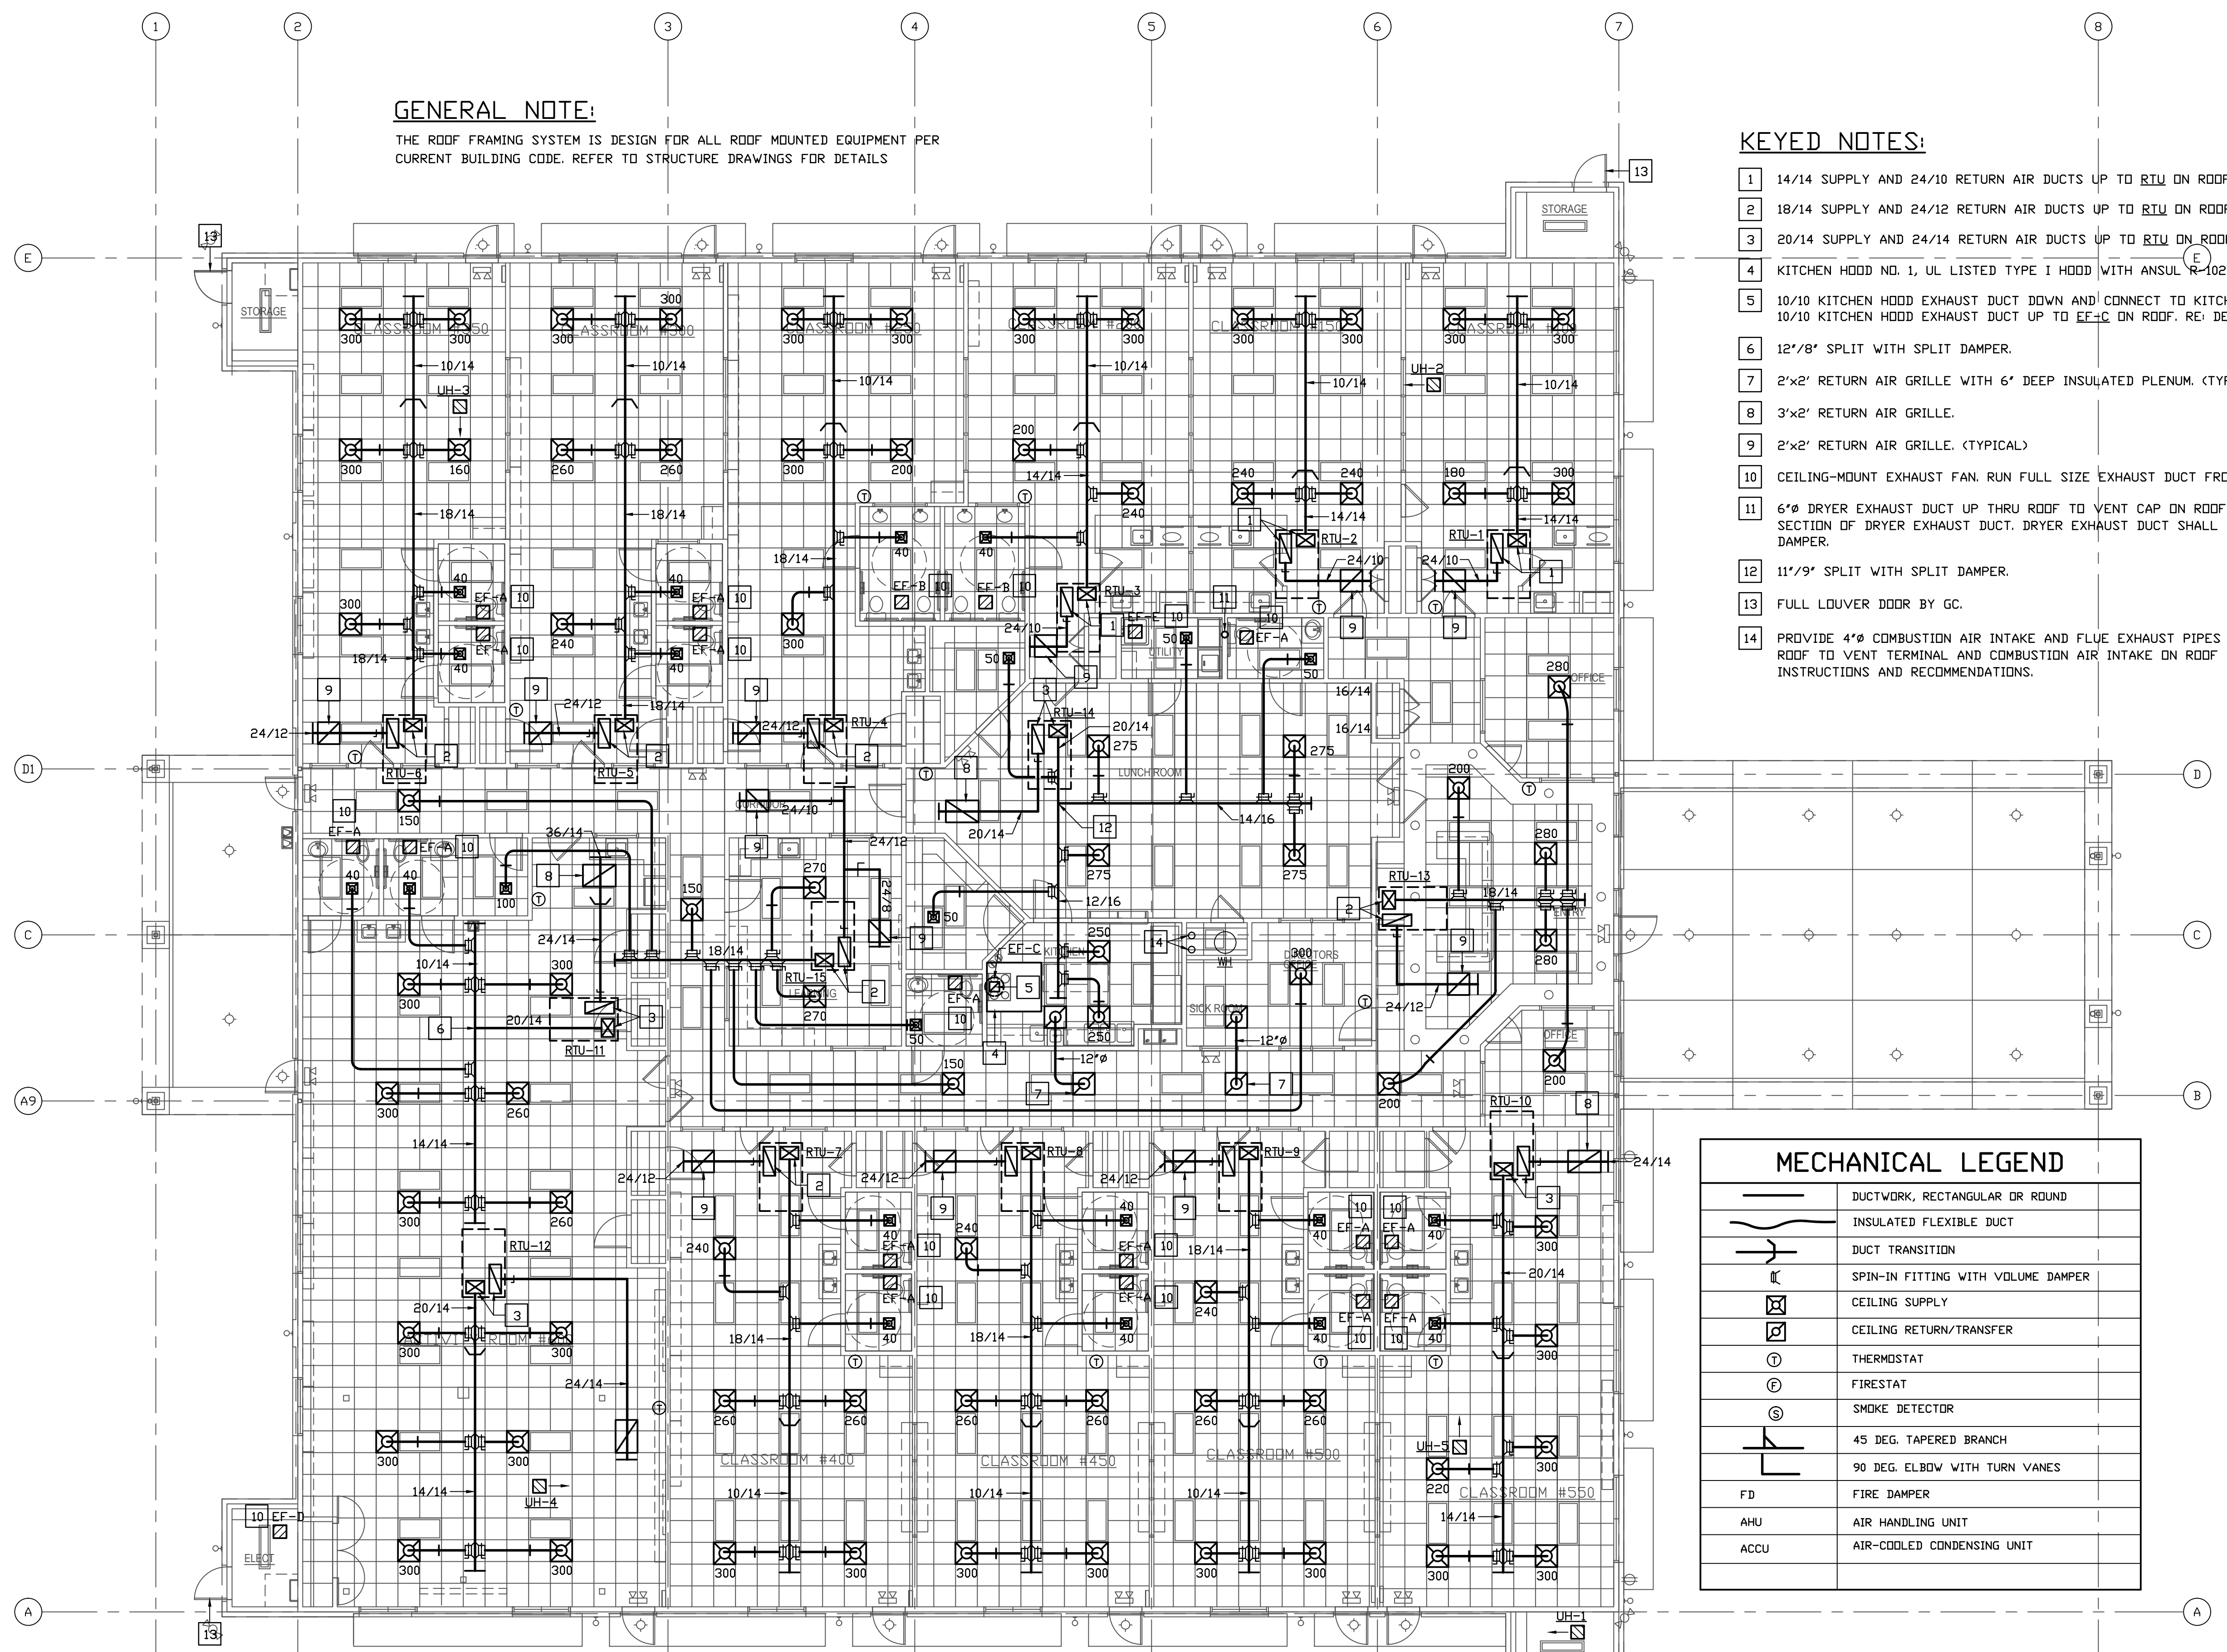

MECHANICAL LEGEND	
	DUCTWORK, RECTANGULAR OR ROUND
	INSULATED FLEXIBLE DUCT
	DUCT TRANSITION
	SPIN-IN FITTING WITH VOLUME DAMPER
	CEILING SUPPLY
	CEILING RETURN/TRANSFER
	THERMOSTAT
	FIRESTAT
	SMOKE DETECTOR
	45 DEG. TAPERED BRANCH
	90 DEG. ELBOW WITH TURN VANES
	FIRE DAMPER
	AIR HANDLING UNIT
	AIR-COOLED CONDENSING UNIT

IVY KIDS EARLY LEARNING CENTER
 4434 CR 94
 Manvel, Tx 77578

MEP Consultants
 BLK Engineering & Consulting Co.
 3423 Spring Arbor Ln.
 Sugar Land, TX 77479
 (t) 832 563 3127
 TBPE Firm #12672



DRAWING TITLE
MECHANICAL FLOOR PLAN

DRAWN BY FK	CHECKED BY CK
DATE 03/30/2017	JOB NO. sedona lakes
DRAWING NO. M-1.0	

01 FLOOR PLAN - MECHANICAL
 SCALE: 1/8" = 1'-0"